


NORTH WING

WEST WING

EAST WING

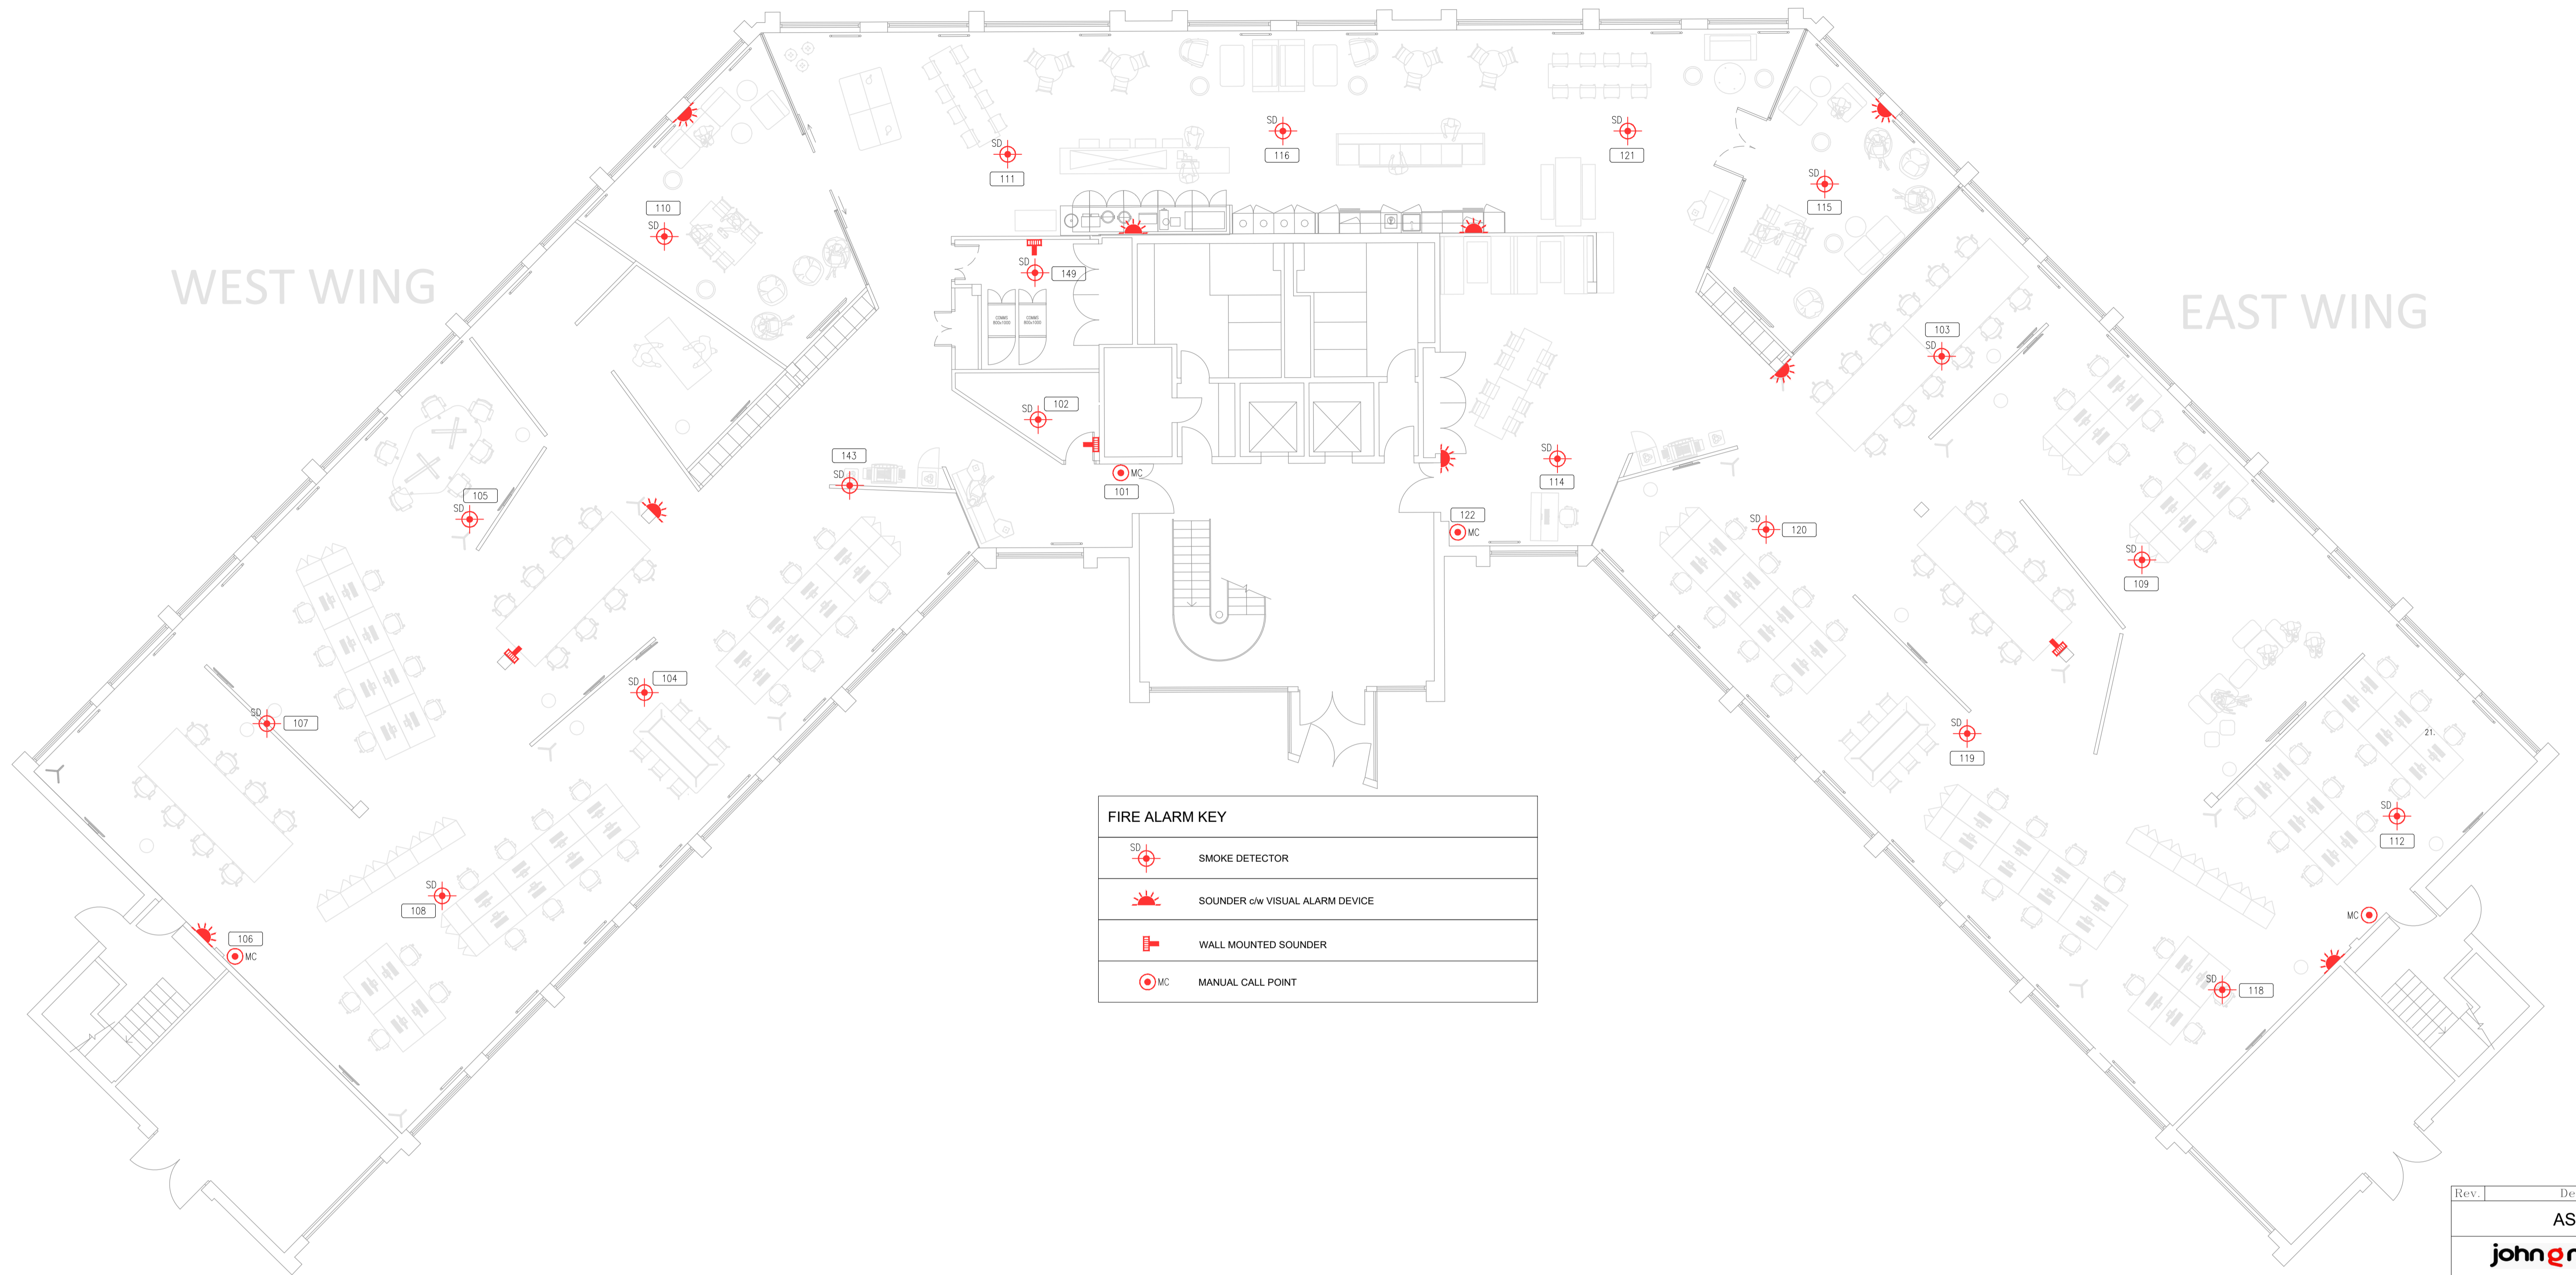

FIRE ALARM KEY	
	SMOKE DETECTOR
	SOUNDER or VISUAL ALARM DEVICE
	WALL MOUNTED SOUNDER
	MANUAL CALL POINT

Rev.	Description	Date
	AS FITTED	
30 DRYDEN ROAD EDINBURGH EH20 9LZ TEL 0131 668 1168 FAX 0131 668 1161		
Client		
Instant Group		
Project		
Cornerstone South Gyle Crescent Edinburgh		
Drawing Title		
GROUND FLOOR FIRE ALARM LAYOUT		
Scale	1:100 @ A1	Date
		MARCH 2018
Engineer	LS	Checked
		GF
Stage	Drawing No.	Rev.
	C180071(AF)(6B)100	-