


KEY

PICTOGRAMS/NOTES
 1. To Contact Designer B2/08/06
 2. To Contact Designer B2/08/06
 3. To Contact Designer B2/08/06
 4. To Contact Designer B2/08/06
 5. To Contact Designer B2/08/06
 6. To Contact Designer B2/08/06

RECOMMENDED INSTALLATION HEIGHTS
 Above doors: 2.0m-2.2m from floor to top of sign
 Directional wall fixed signs: 1.7m-2.0m from floor to base of sign

ONE HOUR FIRE SEPARATION
 HALF HOUR FIRE SEPARATION

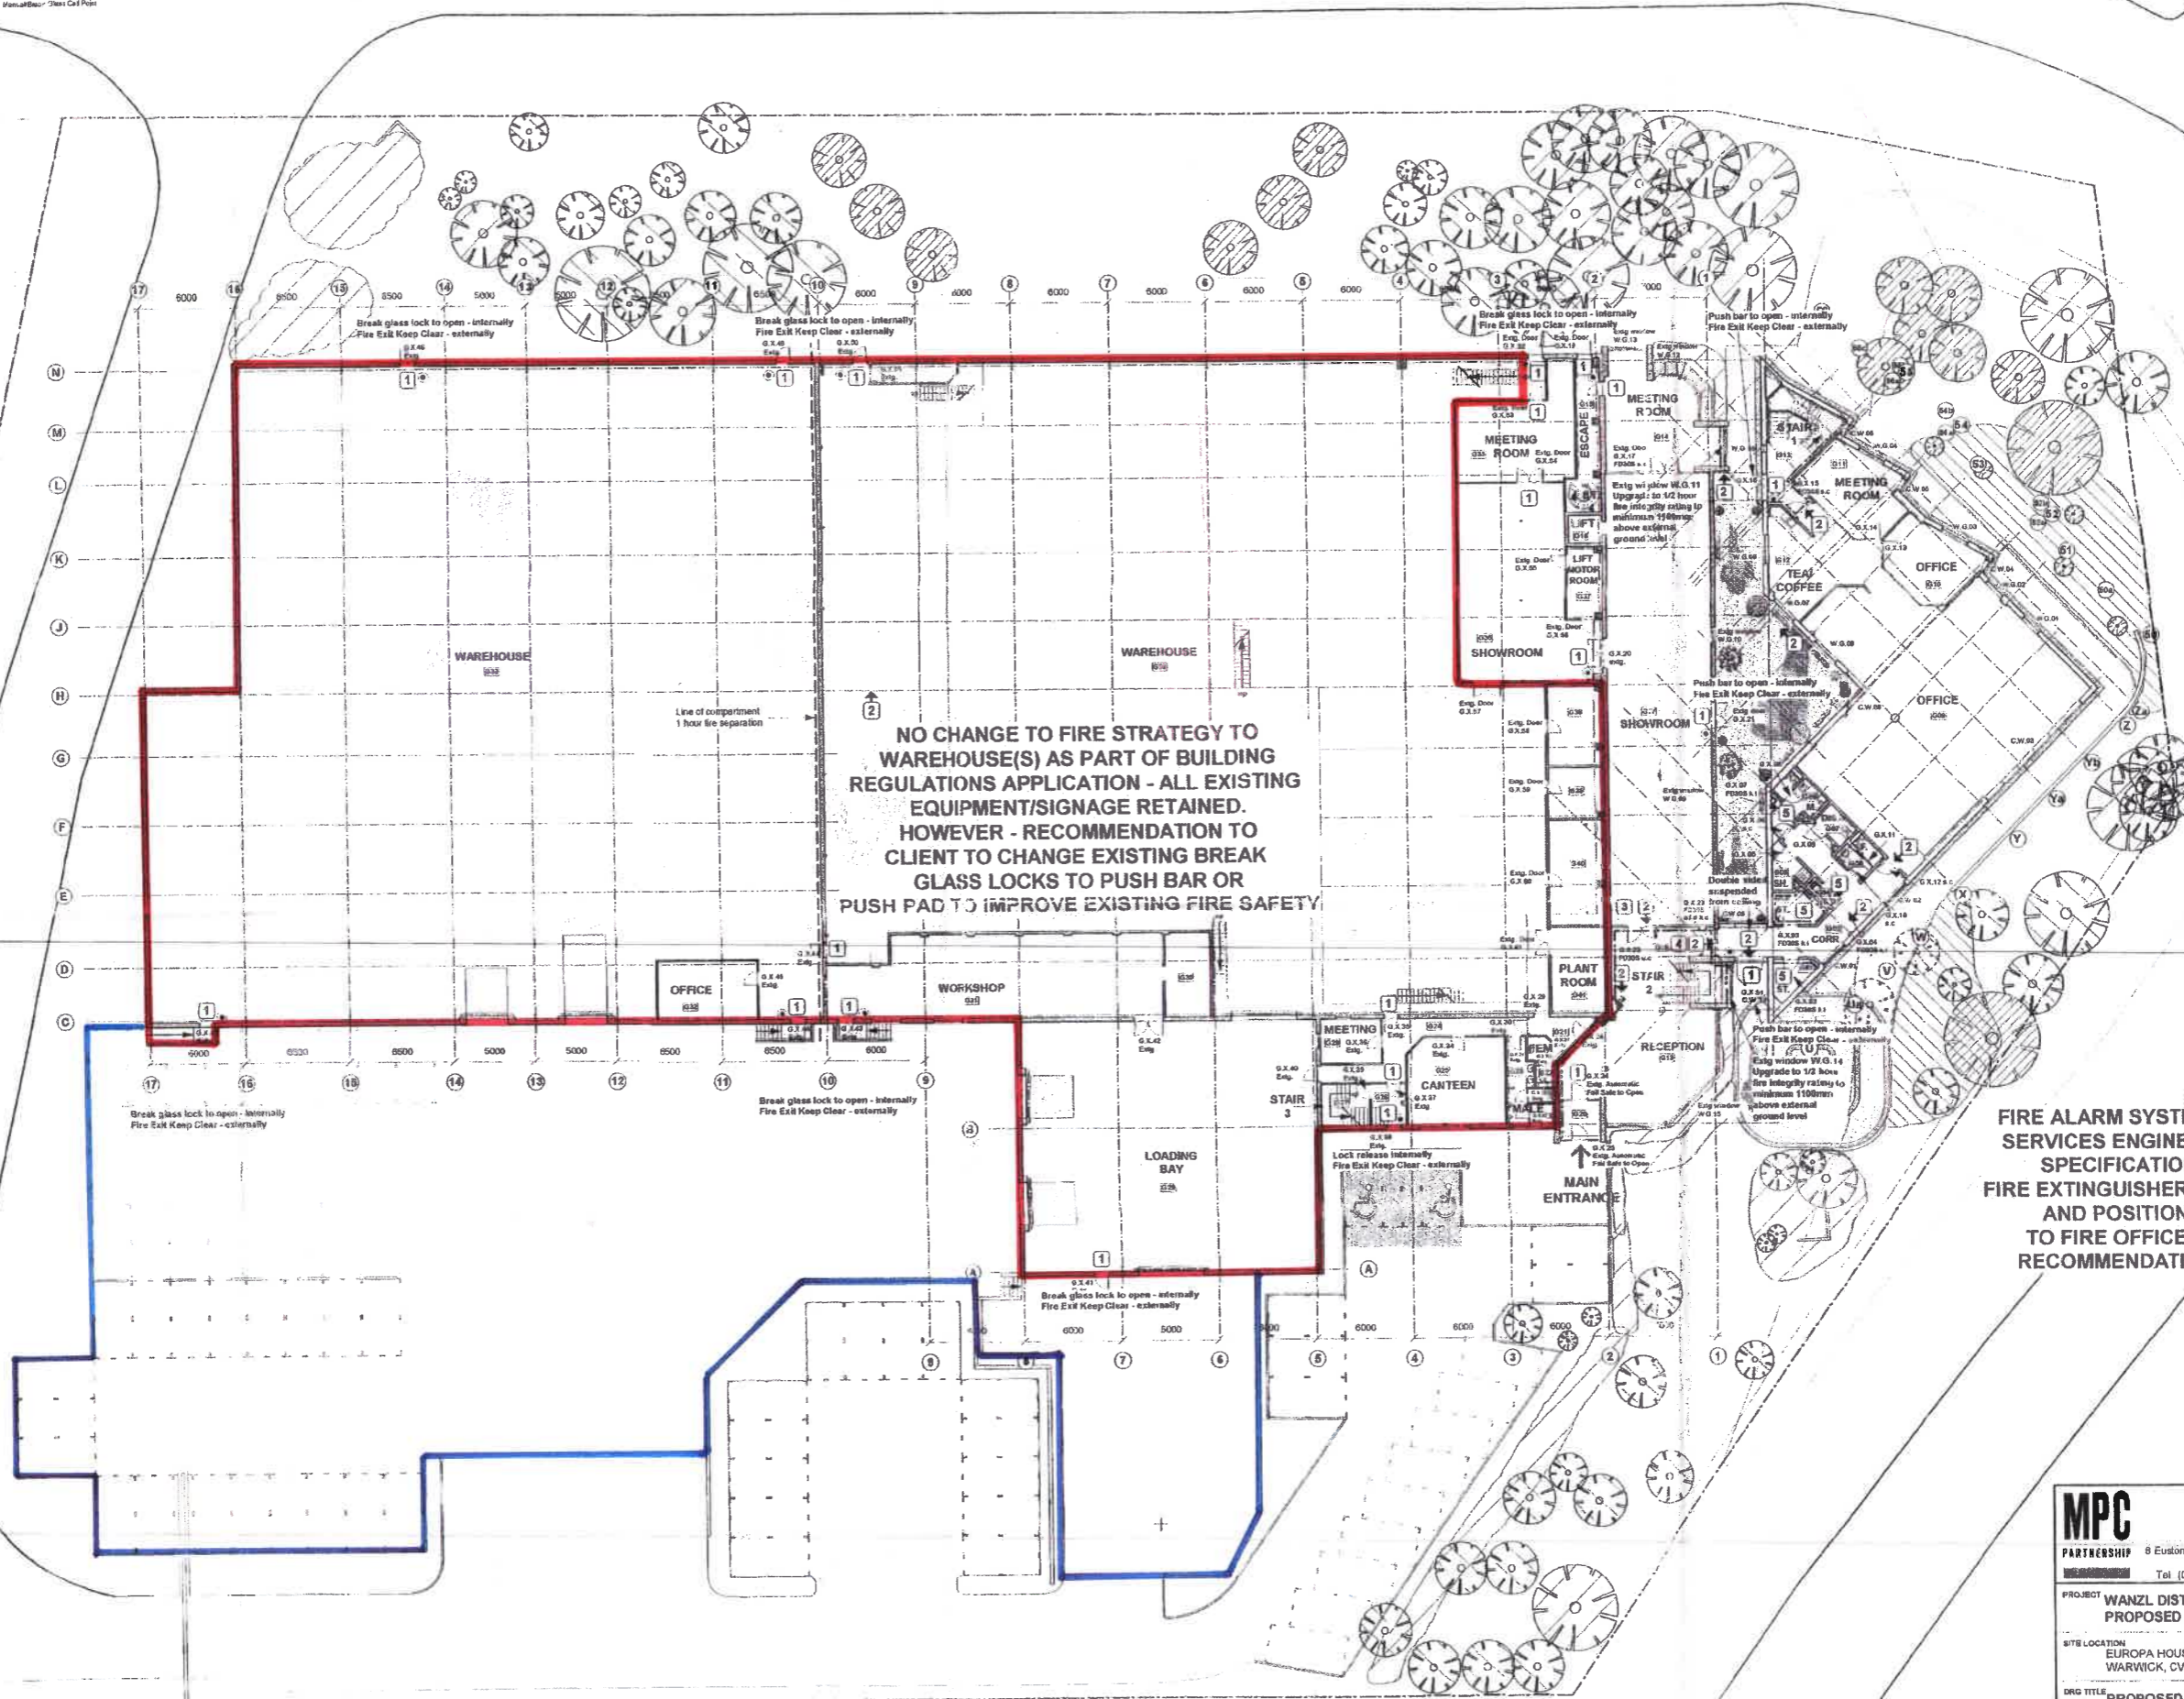

FIRE ALARM SYSTEM TO SERVICES ENGINEER'S SPECIFICATION.
 FIRE EXTINGUISHER TYPES AND POSITIONS TO FIRE OFFICER'S RECOMMENDATIONS

MPC
 PARTNERSHIP
 8 Euston Place, Royal Leamington Spa, CV32 4LN
 Tel: 01926 833355 Fax: 888888

PROJECT: **WANZL DISTRIBUTION CENTRE PROPOSED EXTENSION**

SITE LOCATION: EUROPA HOUSE, HEATHCOTE LANE, WARWICK, CV34 6SP

DRG TITLE: **PROPOSED GROUND FLOOR FIRE STRATEGY PLAN**

© copyright: 2005	Drawn by: JM/HKM	Checked by: JM
Scale: 1:200	Date: 07/11/05	Date: 11/11/05
DRG NO.:	574/BR/106	